


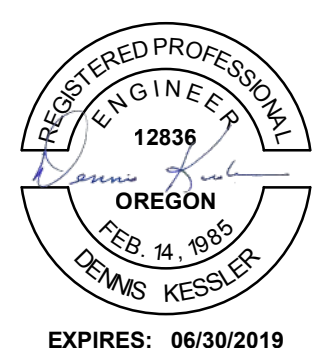


CITY OF OREGON CITY

HAZELWOOD DRIVE SEWER REPLACEMENT - PHASE I


JUNE 2018
VOLUME II OF II



PROJECT VICINITY MAP

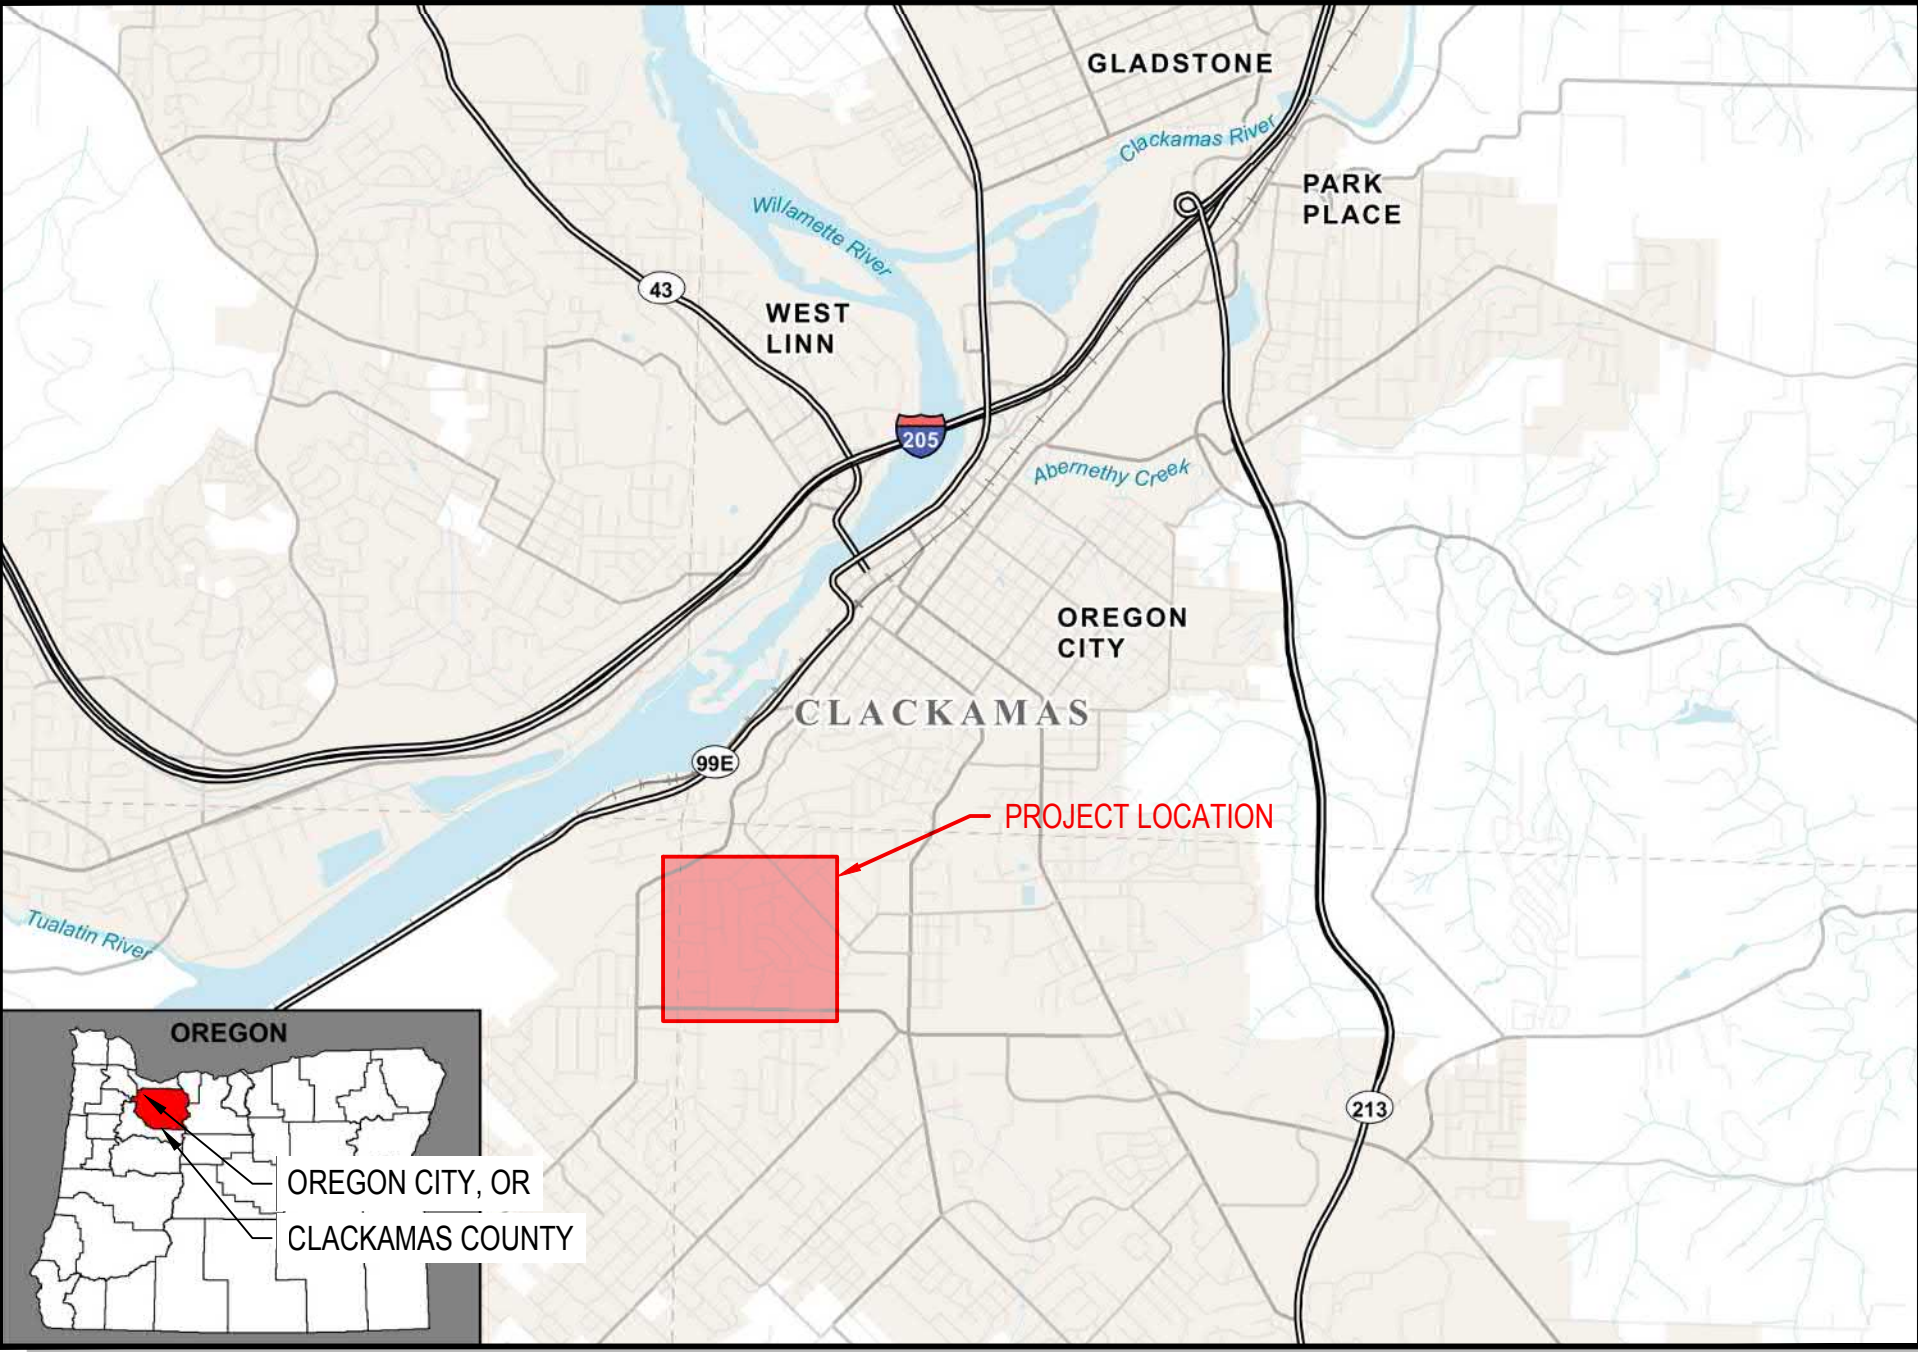

PROJECT LOCATION MAP

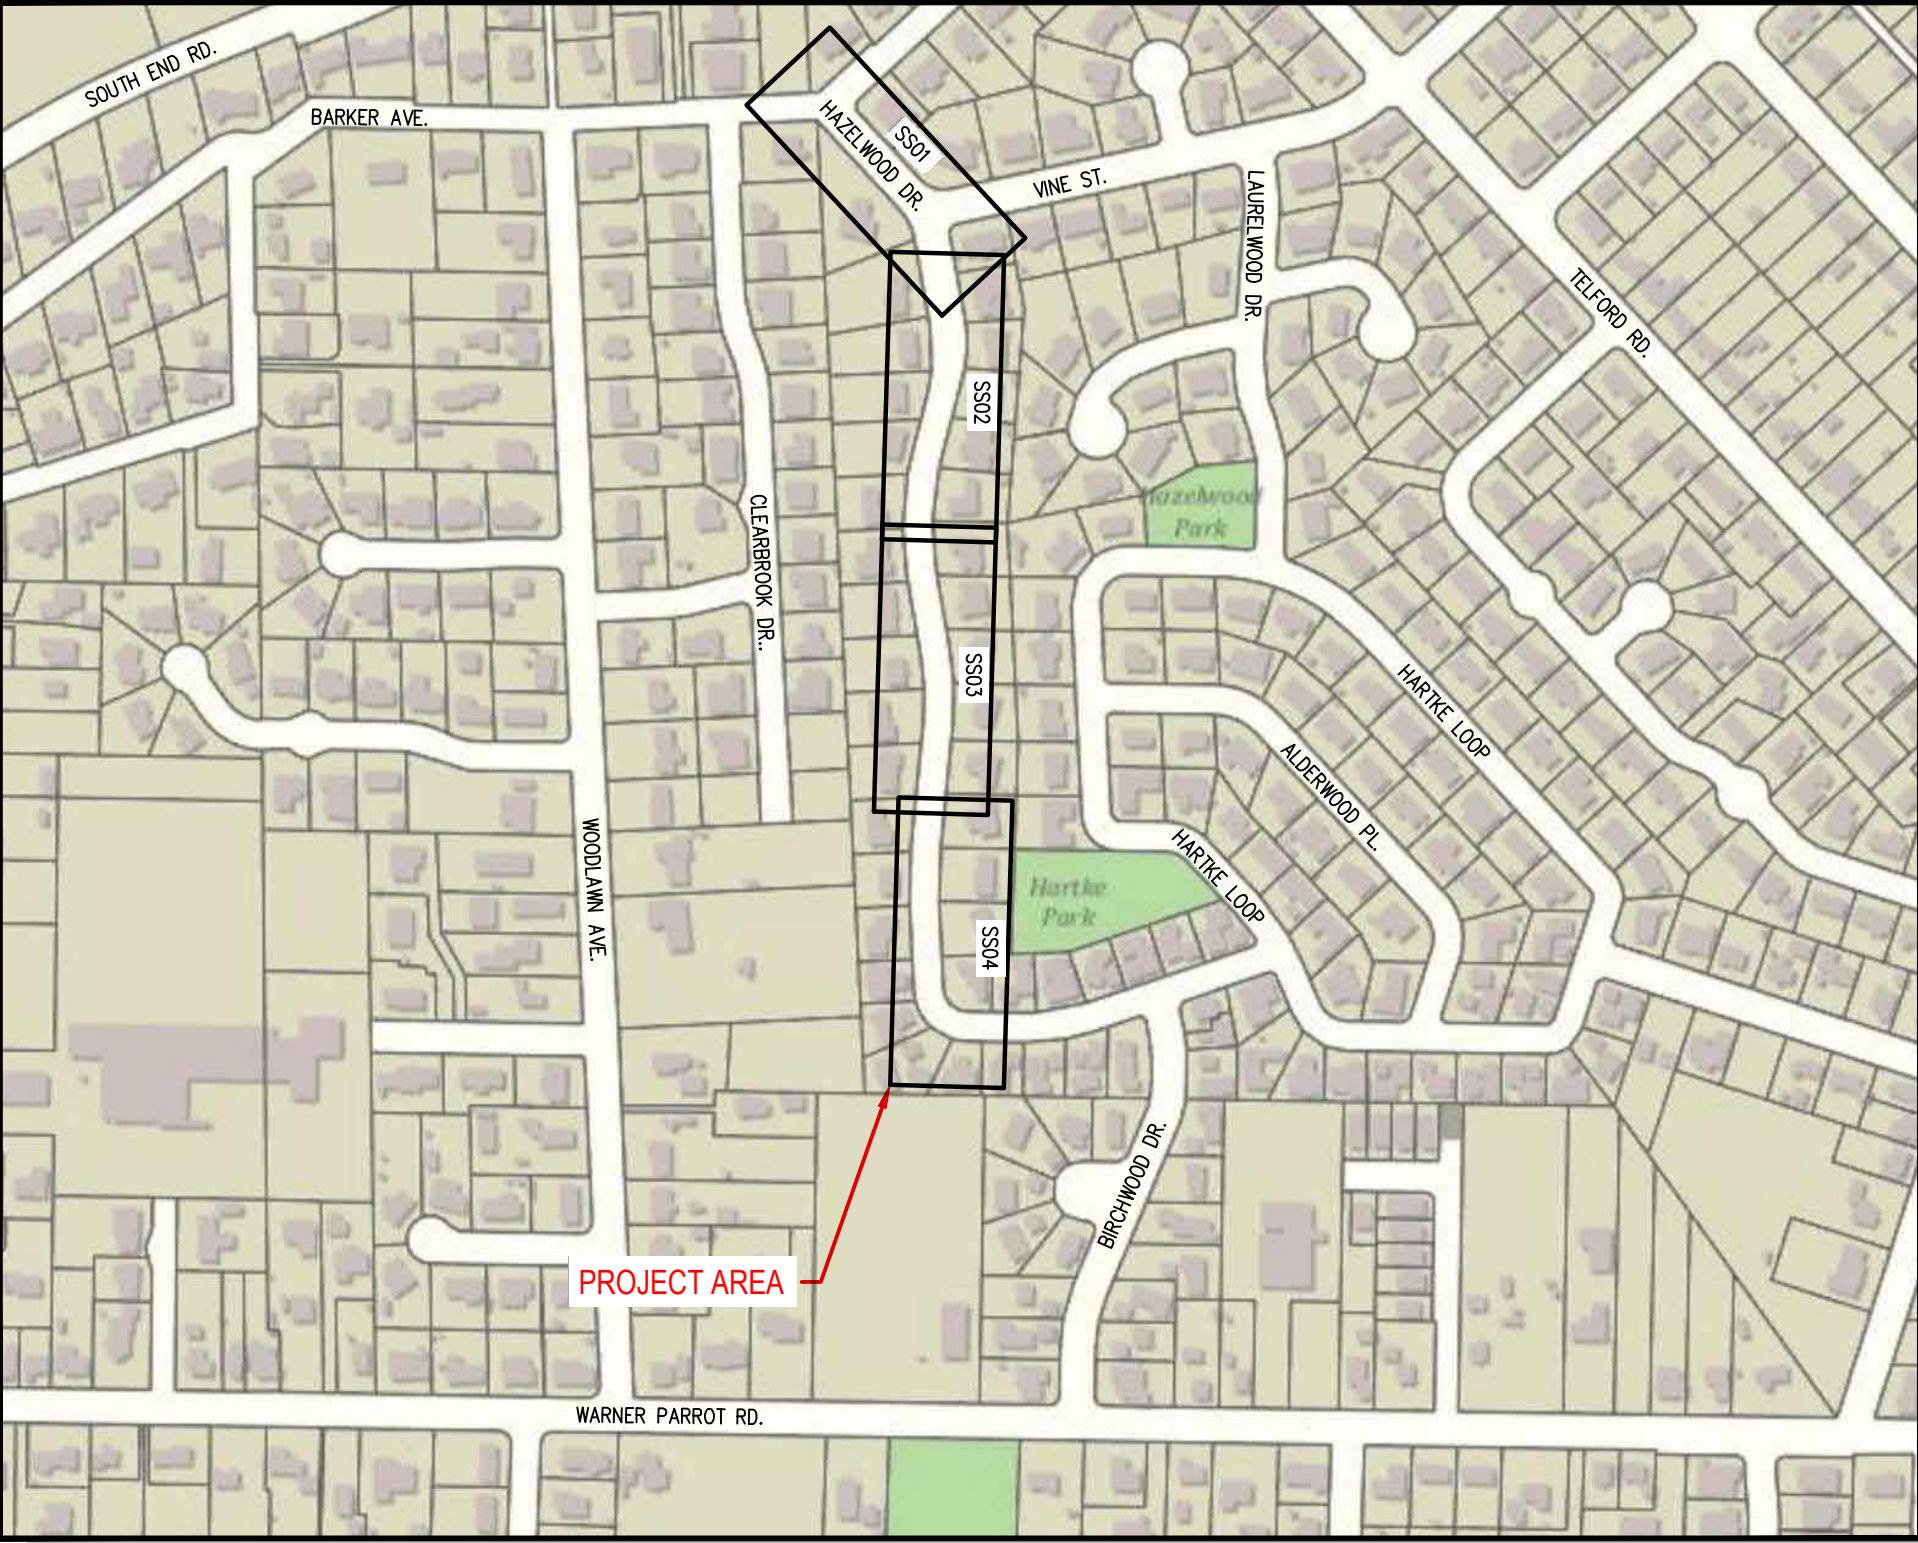

LEGENDS

EXISTING LEGEND

	CONIFEROUS TREE		RIGHT OF WAY LINE
	DECIDUOUS TREE		RIGHT OF WAY CENTERLINE
	WATER METER		PROPERTY LINE
	FIRE HYDRANT		EASEMENT
	WATER GATE VALVE		GRAVEL EDGE LINE
	WATER AIR RELIEF VALVE		ROADWAY CURB
	STORM DRAIN MANHOLE		FENCE
	CATCH BASIN		WOOD FENCE
	CULVERT DAYLIGHT		UNDERGROUND COMMUNICATION
	SANITARY SEWER MANHOLE		NATURAL GAS
	SANITARY SEWER CLEANOUT		UNDERGROUND POWER
	NATURAL GAS METER		OVERHEAD POWER
	NATURAL GAS VALVE		SANITARY SEWER
	POWER VAULT		STORM DRAIN CULVERT
	STREET LIGHT		STORM DRAIN DITCH
	COMMUNICATIONS VAULT		STORM DRAIN LINE
	COMMUNICATIONS RISER		WATER LINE
	SIGN		WATER SERVICE LINE
	MAILBOX		ROADWAY ASPHALT AREA
	DRIVEWAY		CONCRETE AREA
	FOUND MONUMENT		

PROPOSED LEGEND

	GRAVITY SEWER
	GRAVITY SEWER (HDD)
	GRAVITY SEWER (FUTURE)
	SEWER MANHOLE
	SEWER CLEANOUT
	HMA TRENCH PATCH

DRAWING INDEX

SHEET NO.	SHEET TITLE	DWG NO.
01	COVER	COV
02	GENERAL NOTES	G01
03	EROSION CONTROL NOTES AND DETAILS	G02
04	SEWER MAIN PLAN AND PROFILE 1	SS01
05	SEWER MAIN PLAN AND PROFILE 2	SS02
06	SEWER MAIN PLAN AND PROFILE 3	SS03
07	SEWER MAIN PLAN AND PROFILE 4	SS04
08	DETAILS	DT01
09	DETAILS 2	DT02

CONTACT PERSONNEL

CONTACT	AGENCY	PHONE
JONATHAN ARCHIBALD (PROJECT MANAGER)	OREGON CITY	(503) 496-1556
ERIC HAND (WASTE/STORMWATER)	OREGON CITY	(503) 657-8241
KEVIN HANKS (WATER)	OREGON CITY	(503) 657-8241
MARTIN MONTALVO (OPERATIONS)	OREGON CITY	(503) 657-8241
MATT POWLISON (STREETS)	OREGON CITY	(503) 657-8241
KYLE PETTIBONE, P.E.	RH2 ENGINEERING	(503) 446-2816
DENNIS KESSLER, P.E.	RH2 ENGINEERING	(503) 446-2905
JUSTIN BARROW	RH2 ENGINEERING	(503) 446-2911
RICH GIRARD	NW NATURAL GAS	(503) 226-4211
MATT BRAVO	COMCAST	(503) 351-9311
SCOTT MILLER	CENTURY LINK	(503) 242-4144
DAVID MEYER	PORTLAND GENERAL ELECTRIC	(503) 669-5298

CALL 48 HOURS BEFORE YOU DIG
ONE CALL 1-800-332-2344

ATTENTION: OREGON LAW REQUIRES YOU TO FOLLOW RULES ADOPTED BY THE OREGON UTILITY NOTIFICATION CENTER. THOSE RULES ARE SET FORTH IN OAR 952-001-0010 THROUGH OAR 952-001-0090. YOU MAY OBTAIN COPIES OF THE RULES BY CALLING THE CENTER AT 503-232-1978.

PREPARED BY:
RH2
ENGINEERING
40 YEARS
SINCE 1978
PORTLAND, OR
6500 SW Macadam Ave, Suite 125
www.rh2.com 1.800.720.9052



PROJECT NO: CI 16-005
PROJECT MANAGER: JON ARCHIBALD
DATE: May 31, 2018
DRAWN BY: JRB
CHECKED BY: JRB
SCALE: SHOWN

COVER
HAZELWOOD DRIVE SEWER REPLACEMENT - PHASE I
OREGON CITY, OREGON
CITY FILE NO. CI 16-005

REV. NO.	DATE	REVISIONS

DRAWING NUMBER:
COV
SHEET 01 OF 09