




CITY OF OREGON CITY

HAZELWOOD DRIVE SEWER REPLACEMENT - PHASE II

FALL 2018
VOLUME II OF II

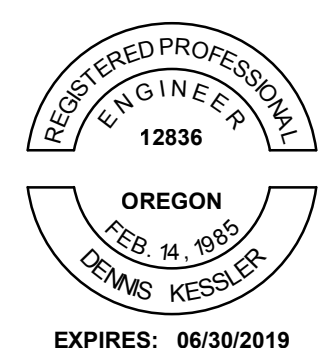

PROJECT NUMBER:	CI 19-006	PROJECT NO.:	917-061	DATE:	Feb 7, 2019
PROJECT MANAGER:	BOB BALGOS, P.E.	DESIGNED BY:	DK	DRAWN BY:	JRB
SCALE:	SHOWN	REVISION:			


RH2 ENGINEERING INC.
6500 SW MACADAM AVE.
SUITE 125
PORTLAND, OREGON 97239

HAZELWOOD DRIVE SEWER REPLACEMENT - PHASE II
OREGON CITY, OREGON
CITY FILE NO. CI 19-006


REV. NO.	DATE	REVISION

DRAWING NUMBER:
COV
SHEET 01 OF 10

PROJECT VICINITY MAP

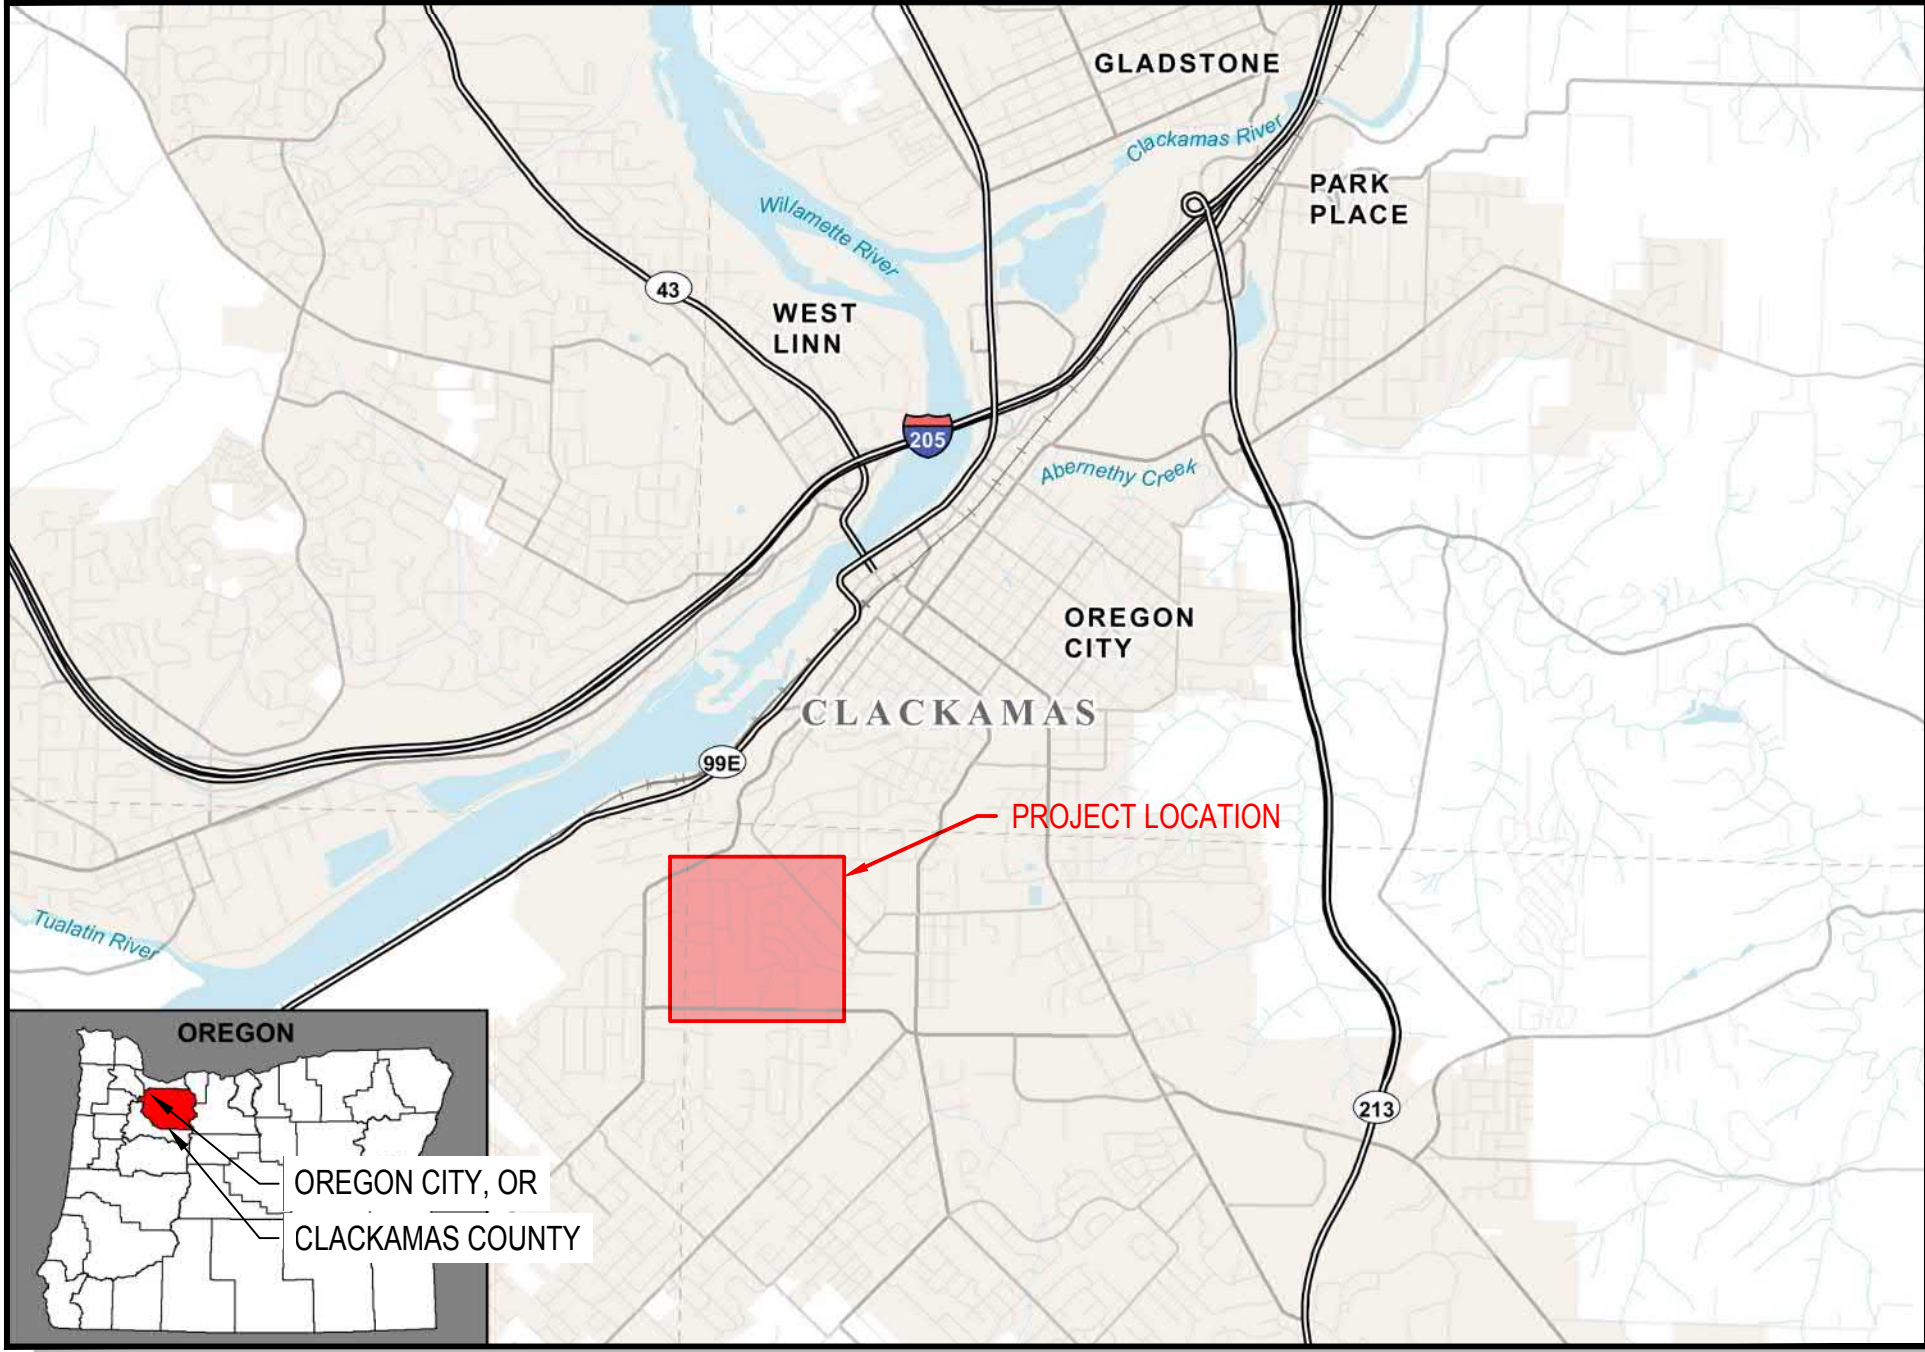

PROJECT LOCATION MAP

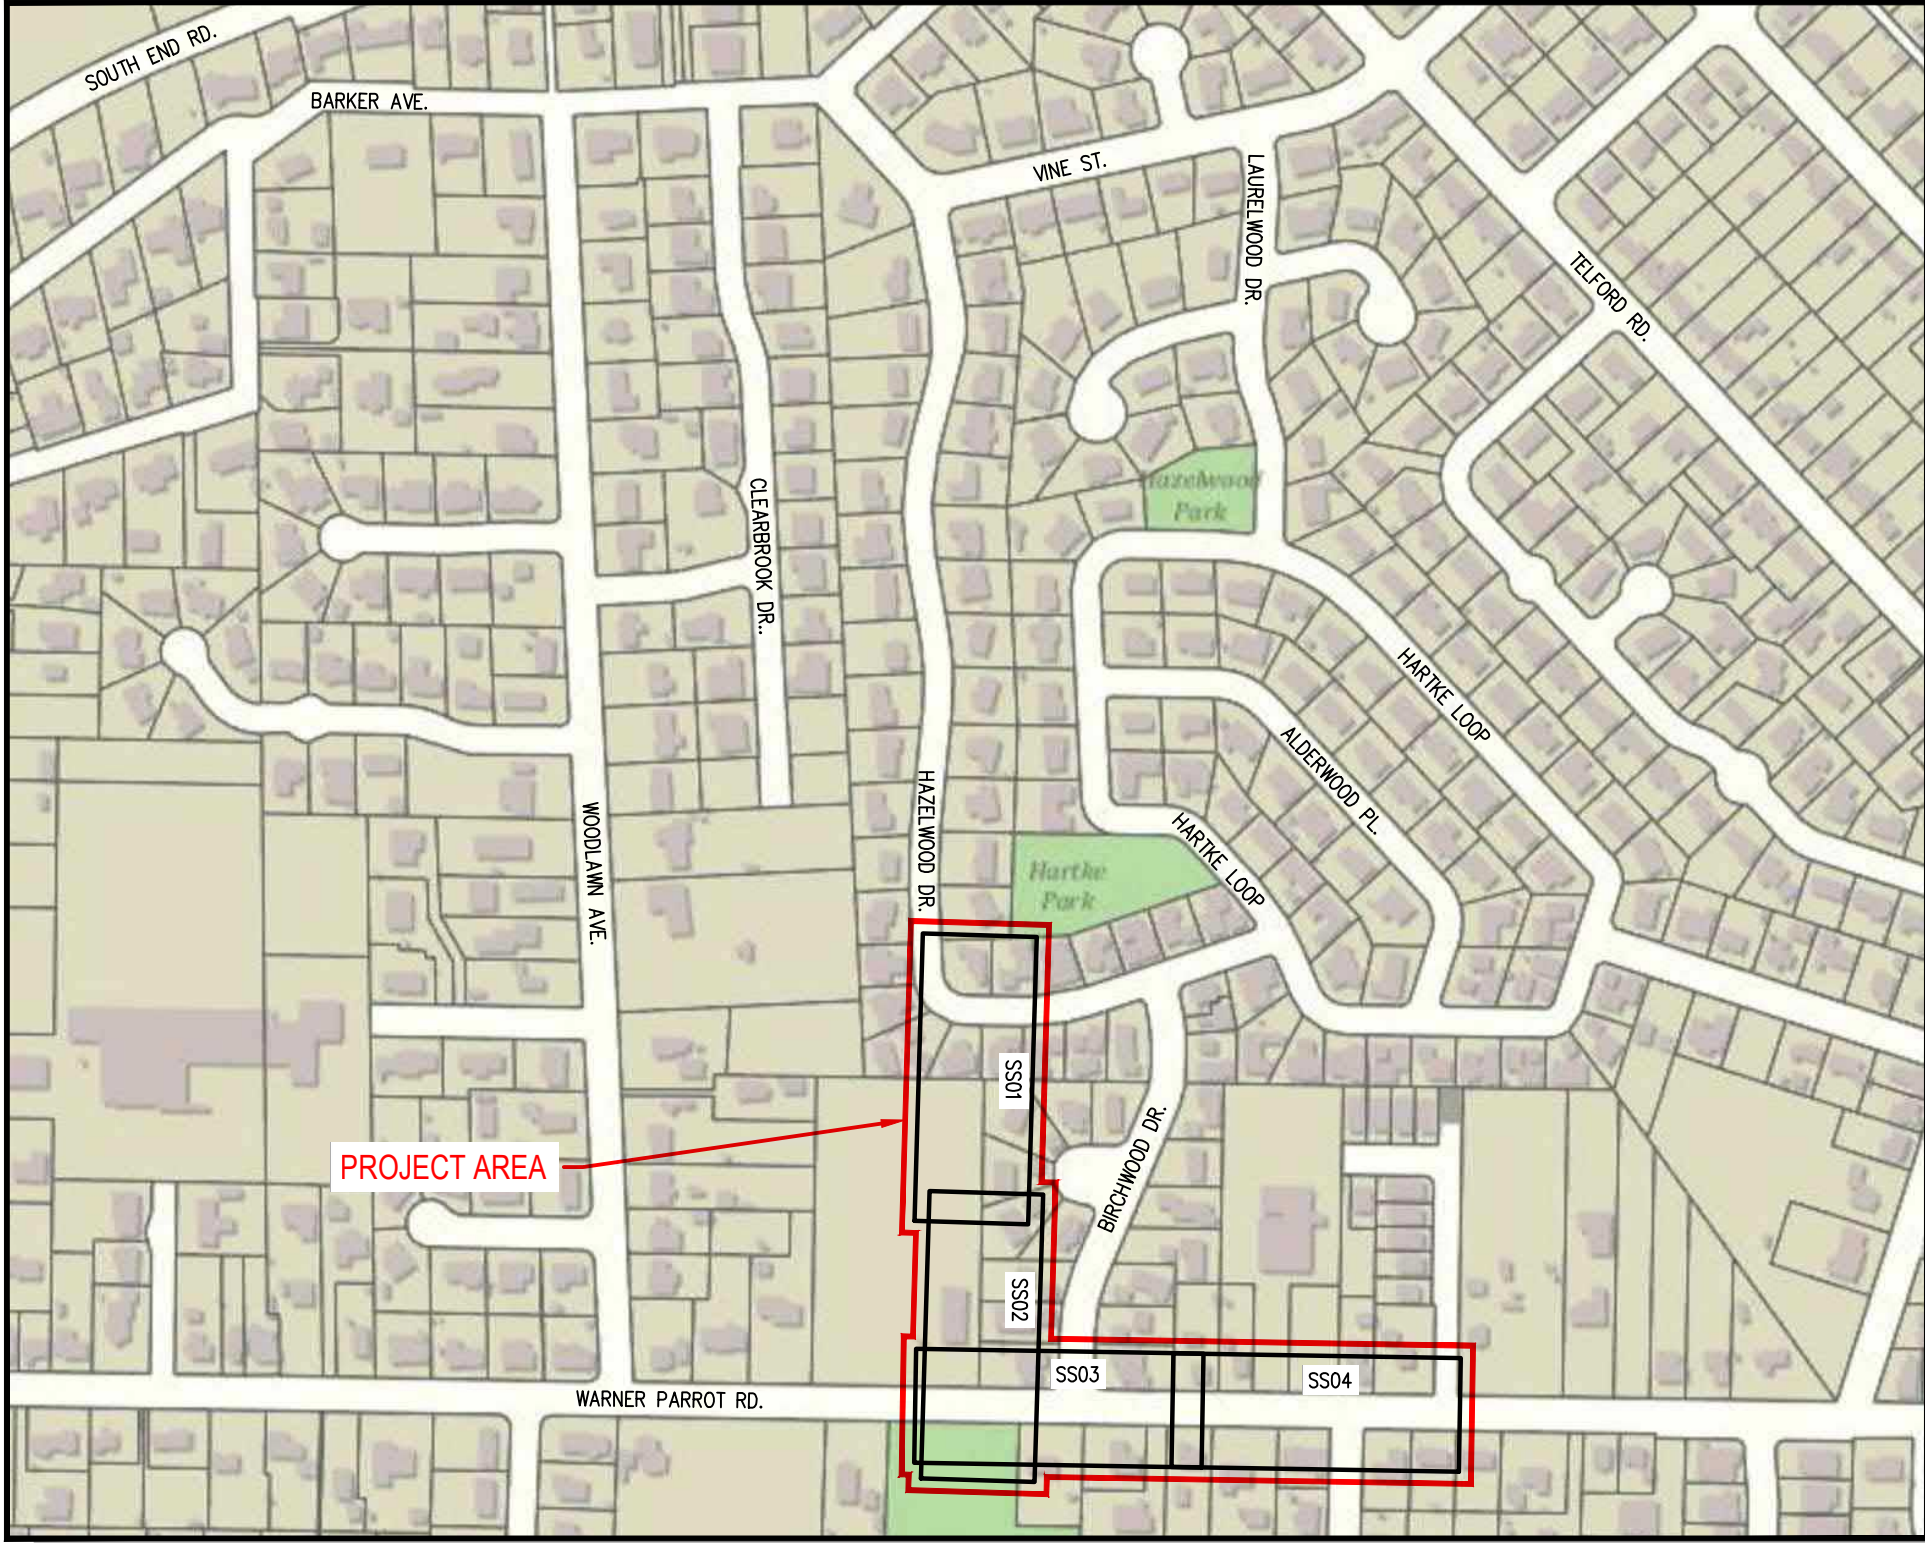

LEGENDS

EXISTING LEGEND

	CONIFEROUS TREE		RIGHT OF WAY LINE
	DECIDUOUS TREE		RIGHT OF WAY CENTERLINE
	WATER METER		PROPERTY LINE
	FIRE HYDRANT		BUILDING EDGE
	WATER GATE VALVE		EASEMENT
	WATER AIR RELIEF VALVE		GRAVEL EDGE LINE
	STORM DRAIN MANHOLE		ROADWAY CURB
	CATCH BASIN		FENCE
	CULVERT DAYLIGHT		WOOD FENCE
	SANITARY SEWER MANHOLE		MAJOR CONTOUR
	SANITARY SEWER CLEANOUT		MINOR CONTOUR
	NATURAL GAS METER		TOP OF SLOPE
	NATURAL GAS VALVE		TOE OF SLOPE
	POWER VAULT		UNDERGROUND COMMUNICATION
	STREET LIGHT		NATURAL GAS
	COMMUNICATIONS VAULT		UNDERGROUND POWER
	COMMUNICATIONS RISER		OVERHEAD POWER
	SIGN		SANITARY SEWER
	MAILBOX		STORM DRAIN CULVERT
	DRIVEWAY		STORM CHANNEL FLOW LINE
	FOUND MONUMENT		ORDINARY HIGH WATER MARK
			STORM DRAIN LINE
			WATER LINE
			WATER SERVICE LINE
			ROADWAY ASPHALT AREA
			CONCRETE AREA
			CULVERT EXTENTS (APPROX.)

PROPOSED LEGEND

	GRAVITY SEWER
	SEWER MANHOLE
	CLEANOUT
	HMA TRENCH PATCH
	SIDEWALK RESTORATION
	RIPRAP
	CONSTRUCTION EASEMENT (TEMP)
	MAJOR CONTOUR
	MINOR CONTOUR

DRAWING INDEX

SHEET NO.	SHEET TITLE	DWG NO.
01	COVER	COV
02	GENERAL NOTES	G01
03	EROSION CONTROL NOTES AND DETAILS	G02
04	SEWER MAIN PLAN AND PROFILE 1	SS01
05	SEWER MAIN PLAN AND PROFILE 2	SS02
06	SEWER MAIN PLAN AND PROFILE 3	SS03
07	SEWER MAIN PLAN AND PROFILE 4	SS04
08	STANDARD DETAILS 1	DT01
09	STANDARD DETAILS 2	DT02
10	CHANNEL RESTORATION DETAILS	DT03

CONTACT PERSONNEL

CONTACT	AGENCY	PHONE
BOB BALGOS, P.E. (PROJECT MANAGER)	OREGON CITY	(503) 974-5518
ERIC HAND (WASTE/STORMWATER)	OREGON CITY	(503) 657-8241
KEVIN HANKS (WATER)	OREGON CITY	(503) 657-8241
JASON THORNBERG (STREETS)	OREGON CITY	(503) 657-8241
KYLE PETTIBONE, P.E.	RH2 ENGINEERING	(503) 446-2816
DENNIS KESSLER, P.E.	RH2 ENGINEERING	(503) 446-2905
JUSTIN BARROW	RH2 ENGINEERING	(503) 446-2911
RICH GIRARD	NW NATURAL GAS	(503) 226-4211
MATT BRAVO	COMCAST	(503) 351-9311
SCOTT MILLER	CENTURY LINK	(503) 242-4144
TONY EAQUINTO	PORTLAND GENERAL ELECTRIC	(503) 463-4350

CALL 48 HOURS BEFORE YOU DIG
ONE CALL 1-800-332-2344

ATTENTION: OREGON LAW REQUIRES YOU TO FOLLOW RULES ADOPTED BY THE OREGON UTILITY NOTIFICATION CENTER. THOSE RULES ARE SET FORTH IN OAR 952-001-0010 THROUGH OAR 952-001-0090. YOU MAY OBTAIN COPIES OF THE RULES BY CALLING THE CENTER AT 503-232-1978.

ABBREVIATIONS

BE	BOTTOM ELEVATION	F/G	FOREGROUND
B/G	BACKGROUND	G	GAS
CONC	CONCRETE	IE	INVERT ELEVATION
CB	CATCH BASIN	MDD	MAX DRY DENSITY
CI	CAST IRON	MH	MANHOLE
CO	CLEANOUT	NOM	NOMINAL
COM	COMMUNICATION	OHW	ORDINARY HIGH WATER
DBH	DIAMETER AT BREAST HEIGHT	P	POWER
DI	DUCTILE IRON	PVC	POLYVINYL CHLORIDE
D/W	DRIVEWAY	PROP	PROPOSED
EL	ELEVATION	SIM	SIMILAR
ELEV	ELEVATION	SS	SANITARY SEWER
EX	EXISTING	STM	STORM
EG	EXISTING GRADE	T	TELEPHONE
FG	FINISHED GRADE	TYP	TYPICAL
		U.N.O	UNLESS NOTED OTHERWISE

PREPARED BY:
RH2
ENGINEERING
40 YEARS SINCE 1978
PORTLAND, OR
6500 SW Macadam Ave, Suite 125
www.rh2.com 1.800.720.9052